


### DOOR SCHEDULE


NO	TYPE	SIZE	NO	TYPE	SIZE	NO	TYPE	SIZE
1	B	3'-0" x 7'-2"	14	D	6'-0" x 7'-0"	27	E	3'-0" x 8'-0"
2	B	2'-6" x 6'-8"	15	F	3'-4" x 6'-8"	28	A	2'-4" x 6'-8"
3	A	2'-6" x 6'-8"	16			29	RG	7'-11" x 6'-8"
4	A	2'-4" x 6'-8"	17			30	A	2'-6" x 6'-8"
5	A	2'-4" x 6'-8"	18			31	H	2'-4" x 6'-8"
6	F	3'-4" x 6'-8"	19					
7	F	4'-0" x 6'-8"	20	A	2'-6" x 6'-8"			
8	E	8'-0" x 8'-0"	21	G	10'-4" x 6'-8"			
9	A	1'-8" x 6'-8"	22	A	2'-4" x 6'-8"			
10	A	2'-6" x 6'-8"	23	A	2'-4" x 6'-8"			
11	E	6'-0" x 8'-0"	24	A	1'-8" x 6'-8"			
12	A	1'-10" x 6'-8"	25	A	2'-6" x 6'-8"			
13	C	3'-0" x 6'-8"	26	A	2'-4" x 6'-8"			

HOLLOW CORE MASONITE 3/8"  
 SOLID CORE PAINT GRADE HWD. 3/4"  
 PLYWOOD 20" H x 3" DES.  
 PLYWOOD  
 TYPE A TYPE P3 TYPE C TYPE D  
 ALUM. SLIDING GLASS  
 PAIR HOLLOW CORE PLYWOOD 1 1/2"  
 METAL SLIDING 1 1/2"  
 MASONITE DOCKET 1 1/8"  
 TYPE E TYPE F TYPE G TYPE H

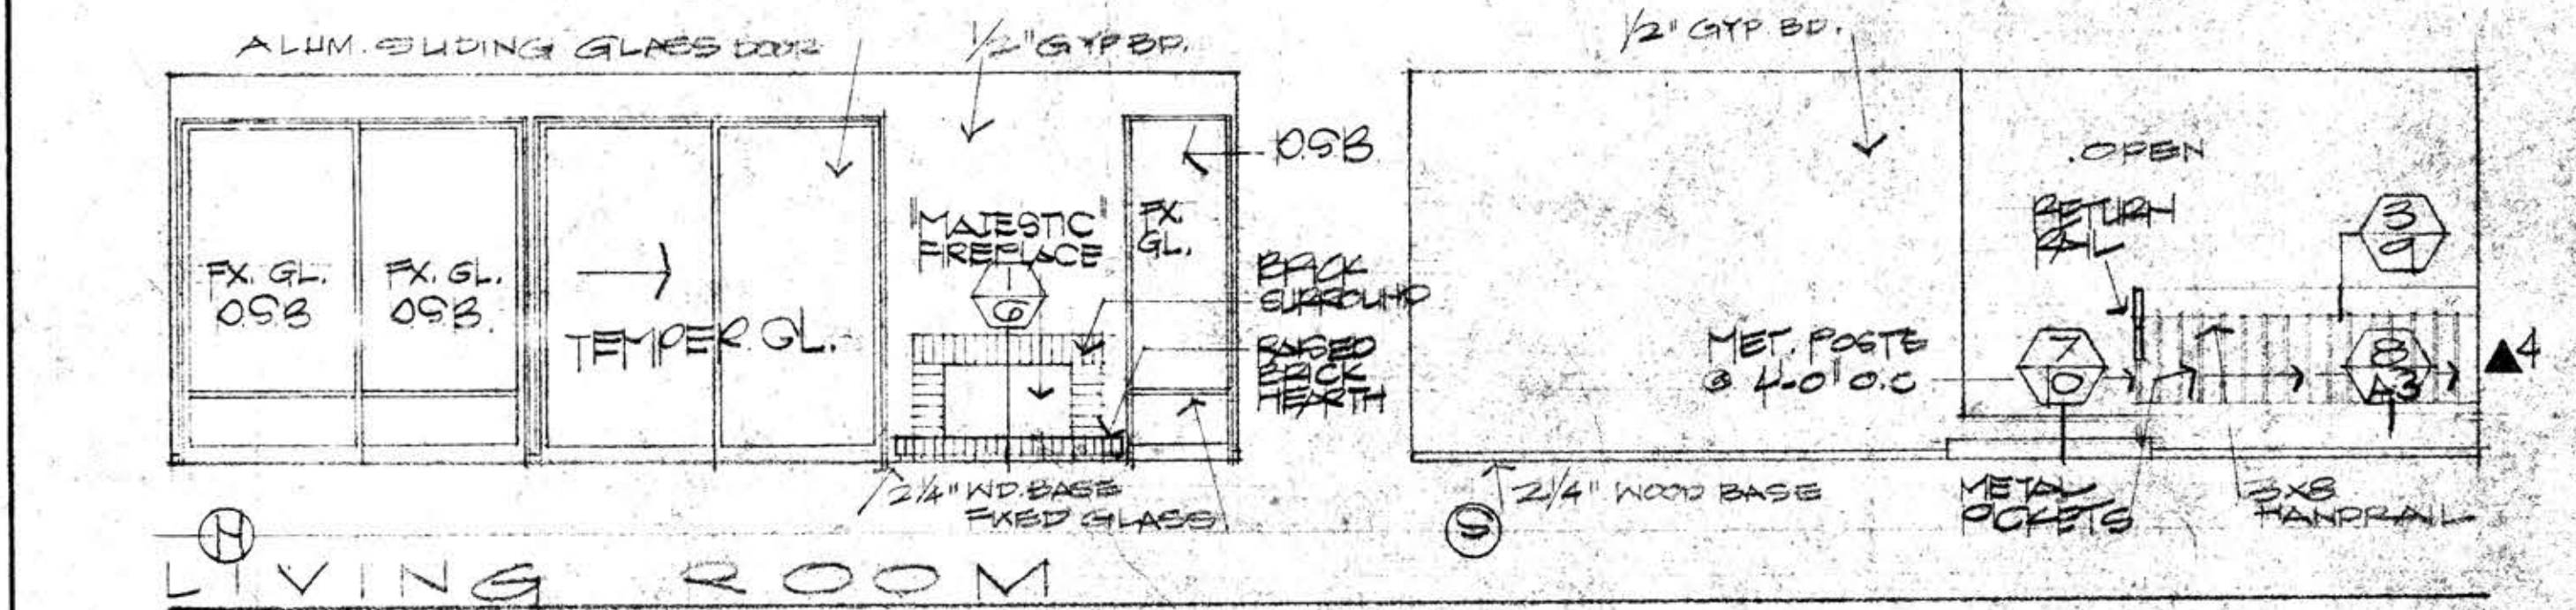

### FINISH SCHEDULE

ROOMS	FLOOR	WALLS	CEILING	REMARKS
ENTRY	QUARRY TILE	2 1/4" WOOD	1/2" GYP. BOARD	
PURCHASE	OMIT	OMIT		
UTILITY	SHEET RESILIENT	4" RUBBER		3/8" GYP. BD. @ PARTY WALLS
POWDER ROOM	SHEET RESILIENT	4" RUBBER		
STORAGE	SHEET RESILIENT	4" RUBBER		
STAIRWELL	CARPETING	2 1/4" WOOD		
DINING ROOM	CARPETING			
LIVING ROOM	CARPETING			
KITCHEN	SHEET RESILIENT	RESILIENT COVE		
NOOK	SHEET RESILIENT	4" RUBBER		
GARAGE	EXPOSED CONC.	CONC. CURB		3/8" GYP. BD. BETWEEN LIVING AREA AND GARAGE AND AT PARTY WALL
HALL	CARPETING	2 1/4" WOOD	1/2" GYP. BOARD	3/8" GYP. BD. @ PARTY WALLS
BATH	SHEET RESILIENT	4" RUBBER		CERAMIC TILE AT BATH-TUB
MASTER BEDROOM	CARPETING	2 1/4" WOOD		
DRESSING	CARPETING			
MANITY	CARPETING			
MASTER BATH	SHEET RESILIENT	4" RUBBER		CERAMIC TILE AT SHOWER
BEDROOM #2	5/8" OAK STRIP	2 1/4" WOOD		
BEDROOM #3	5/8" OAK STRIP	2 1/4" WOOD		

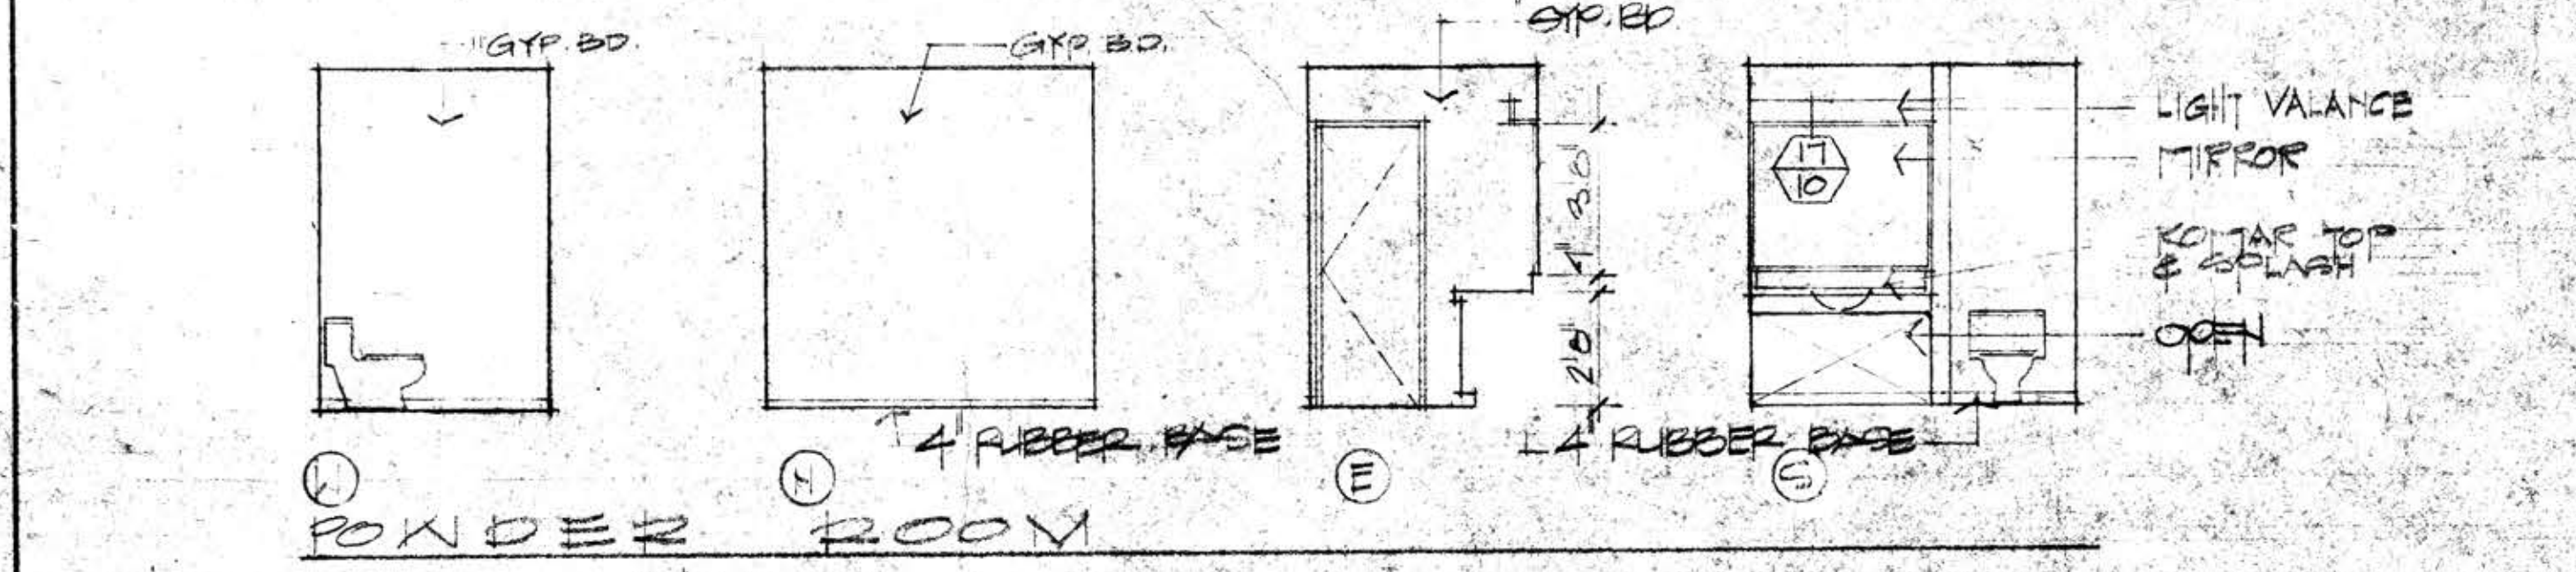




### SYMBOLS

ARCHITECTURAL	ELECTRICAL
⊙ DETAIL NUMBER	⊕ DUPLEX OUTLET
⊙ SHEET NUMBER	⊕ DUPLEX-1 PLUG HOT SWITCHED
⊙ SECTION NUMBER	⊕ SWITCH
⊙ SHEET NUMBER	⊕ 2 WAY SWITCH
⊙ DOOR NUMBER	⊕ TELEPHONE JACK
⊙ FLOOR NUMBER	⊕ FLOOR OUTLET
HP HOSE PIP	⊕ WATERPROOF OUTLET
TO GAS	⊕ EXHAUST FAN
RG ROOF SCUPPER	⊕ CEILING MOUNT. LIGHT FIXTURE
RHL RAIN WATER LEADER	⊕ WALL MOUNT. LIGHT FIXTURE
M.C. MEDICINE CABINET	⊕ INTERROOM
⊕ VACUUM CLEANER OUTLET	⊕ EXHAUST FAN WALL MOUNT
N/C NOT IN CONTRACT	⊕ TELEVISION OUTLET
→ R REGISTER	⊕ SPECIAL OUTLET
→ CAR COLDS AIR RETURN	

### FIXTURE SCHEDULE

FIXT.	MANUFACTURER	MODEL	REMARKS
⊙	PRESCOLITE	CF 10	* SEE NOTE BELOW.
⊙	LIGHT VALANCE		WITH 2-48" FLUORESCENT TUBE
⊙	LIGHT VALANCE		WITH 2-36" FLUORESCENT TUBE
⊙	LYTECASTER	1201-1221	
⊙	BRYANT	522B	KEYLESS
⊙	BRYANT	528B	PULL CHAIN
⊙	CEILING OUTLET		4 2/3" ⌀ ALLOWANCE
⊙	PRESCOLITE	80 RM	
⊙	EMERSON ELECTRIC	821	FAN
⊙	EMERSON ELECTRIC	8010	FAN HEATER LIGHT
⊙	PRESCOLITE	70 RM	
⊙	REFLECT-A-LINE	6024	
⊙	STONCO	150 L	

3 1/2" BOX - EXCLUDE DATE  
 EXTERIOR - BROWN/OTC  
 INTERIOR - MATT WHITE

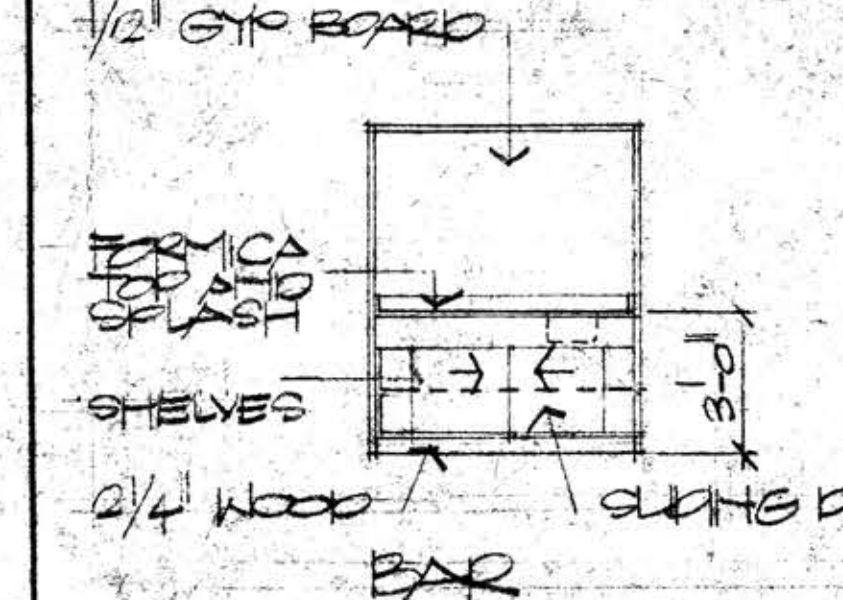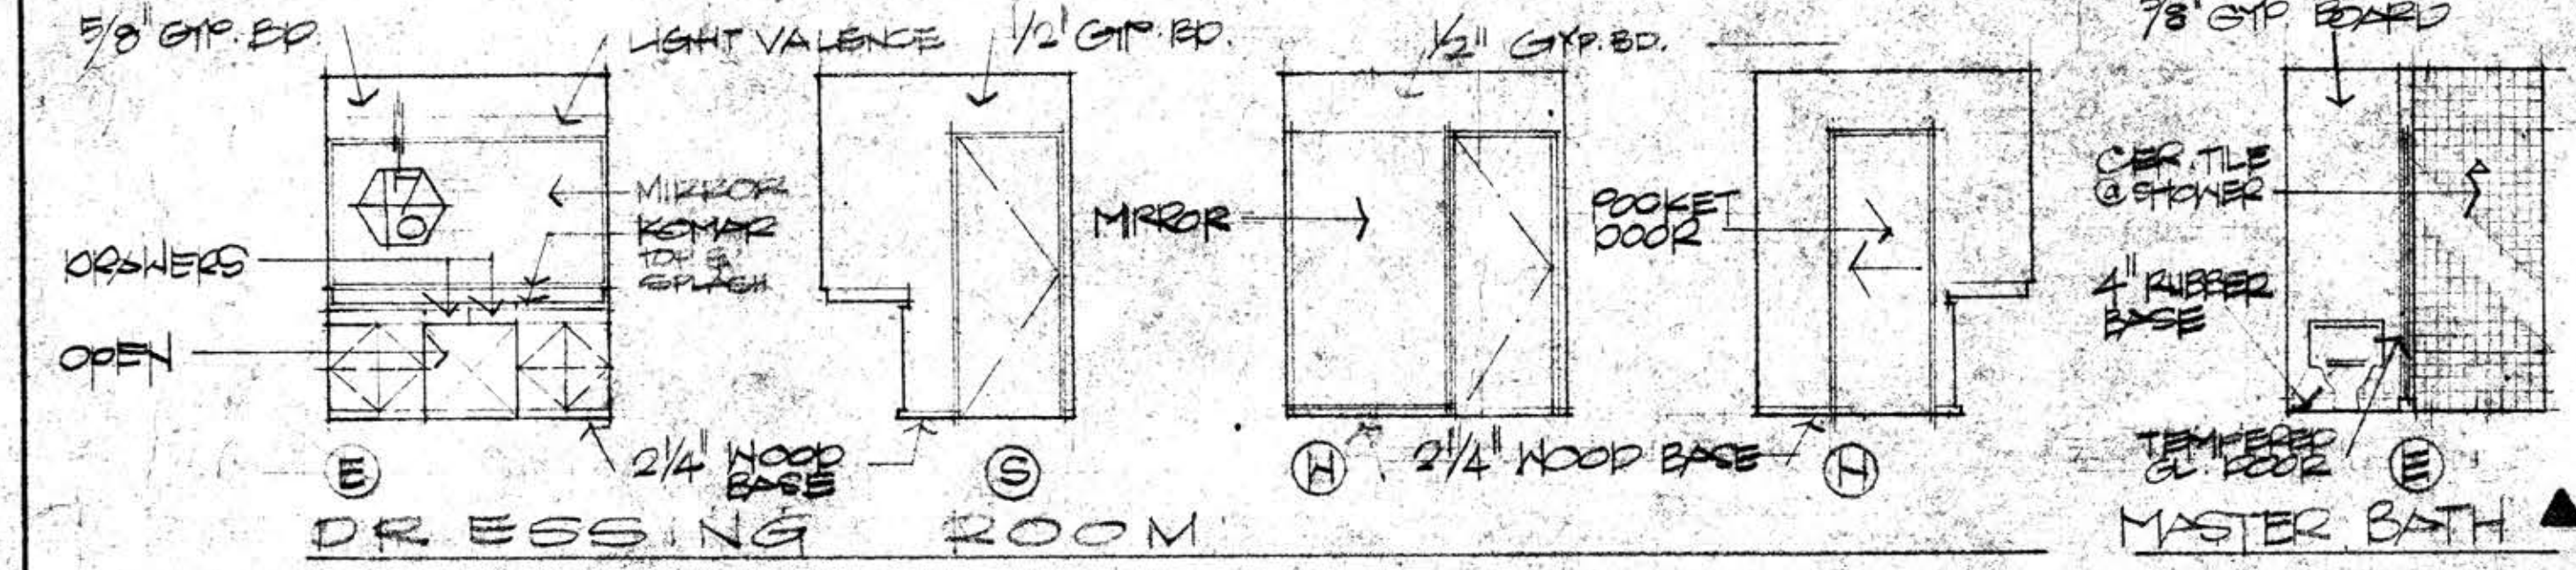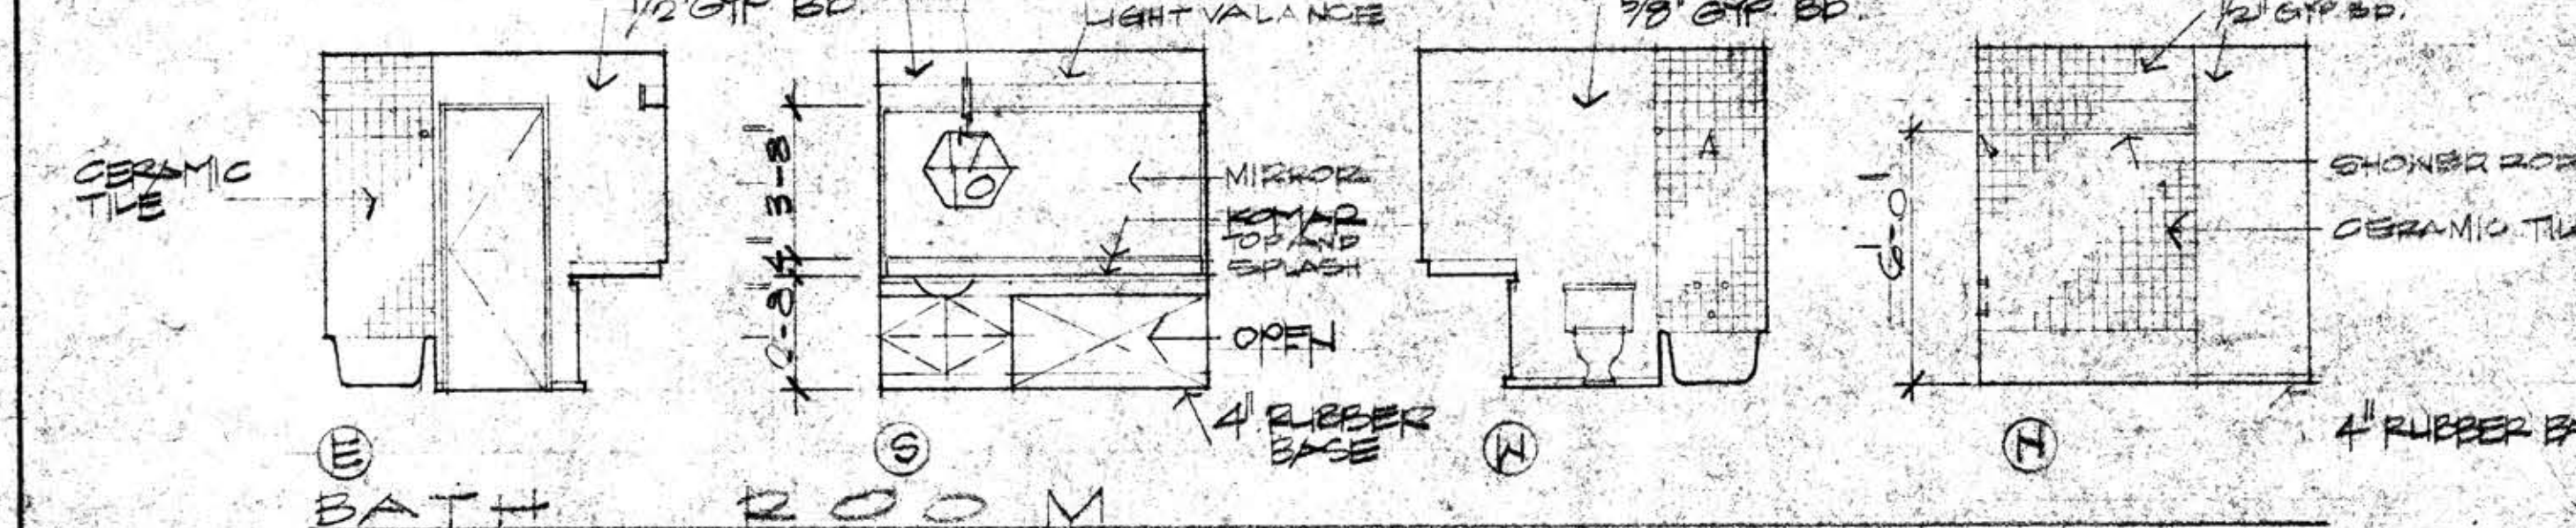

602	⊙	DELETE GYPO AT GARAGE
623	⊙	ADD TO FIXTURE SCHEDULE
624	⊙	CURTAIN AT DINING RM DETAIL
425	⊙	CHANGE DOOR SIZE 3/2
4-1	⊙	ADD BREAD BOARD
1-17	⊙	